


Minneapolis Convention Center - Hall A

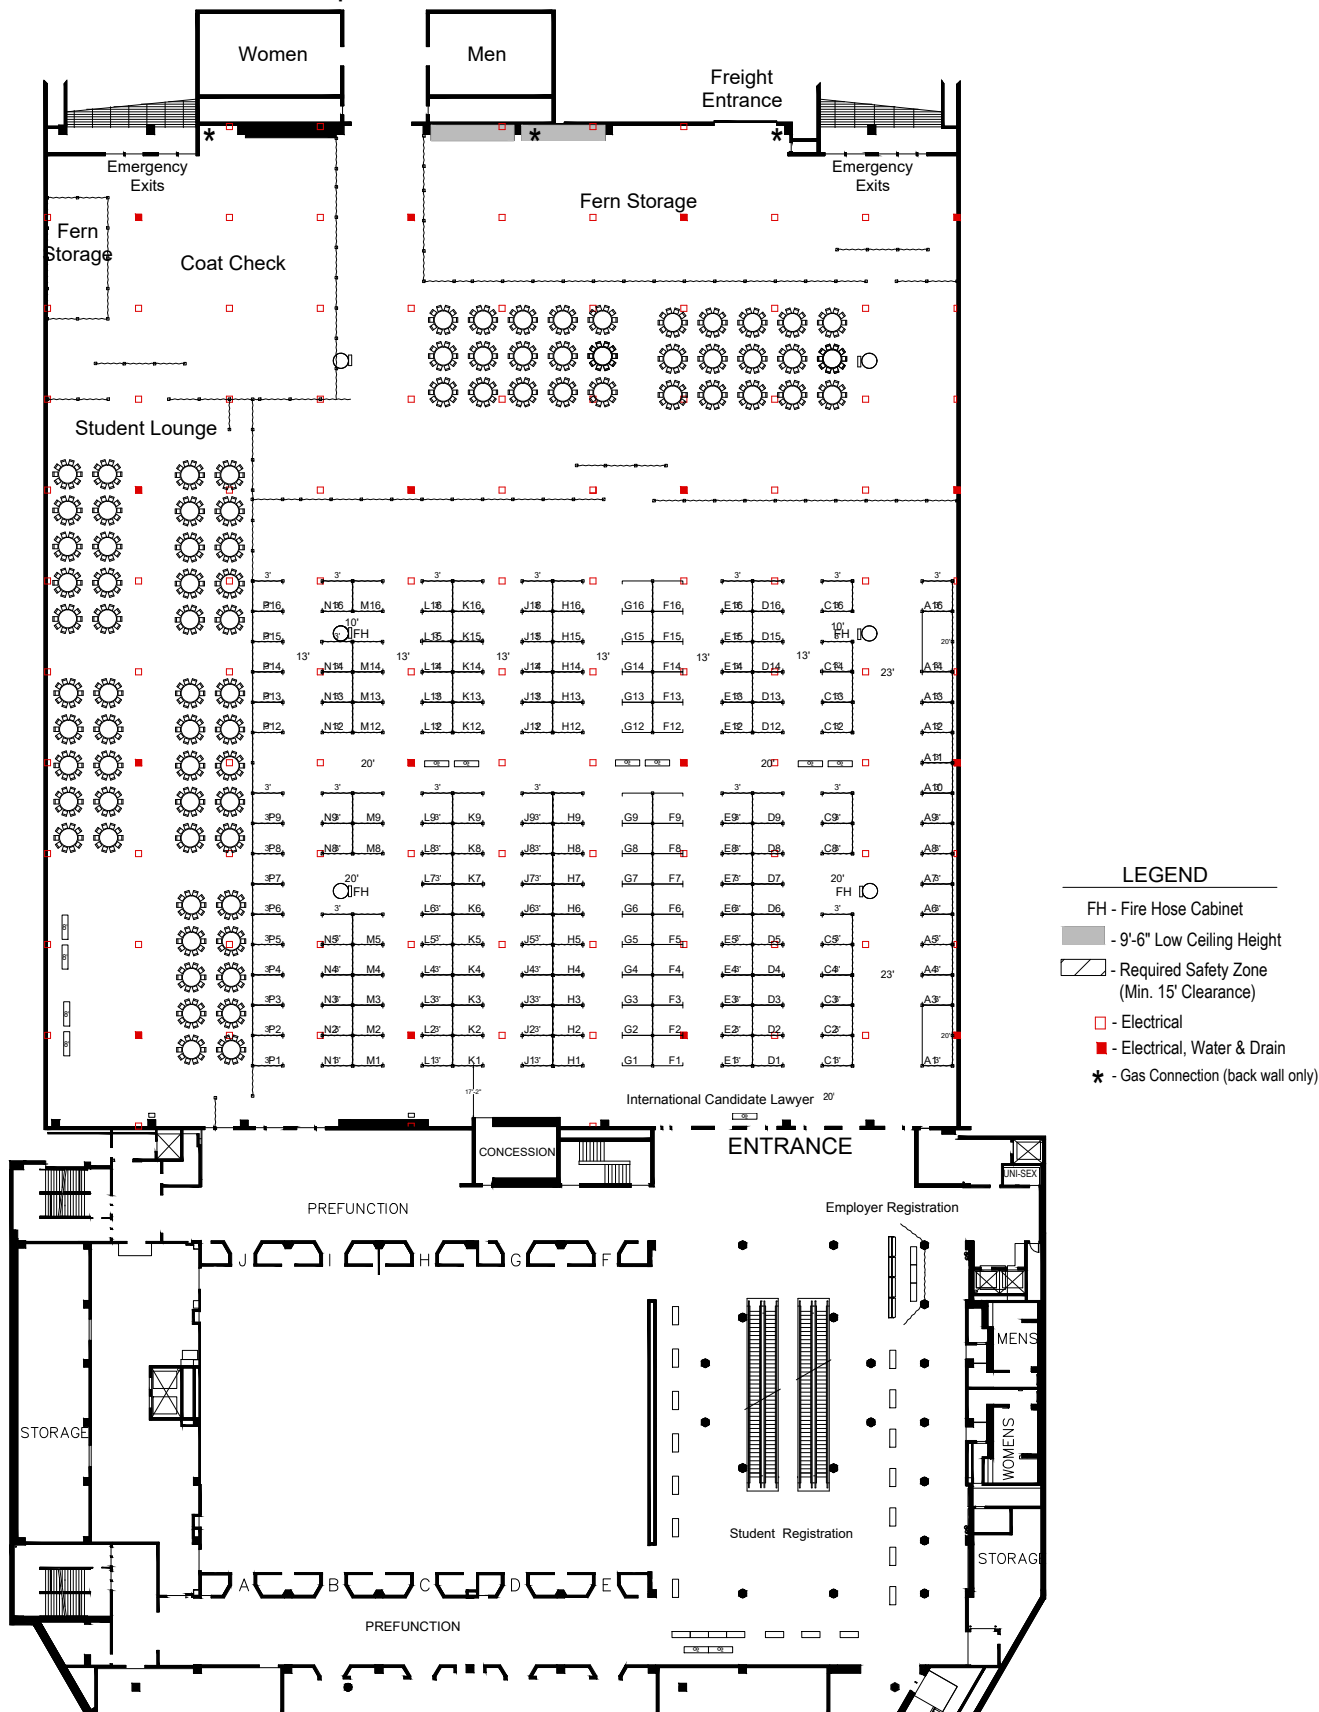

- LEGEND**
- FH - Fire Hose Cabinet
 - - 9'-6" Low Ceiling Height
 - - Required Safety Zone (Min. 15' Clearance)
 - - Electrical
 - - Electrical, Water & Drain
 - * - Gas Connection (back wall only)

Every effort has been made to ensure the accuracy of all information contained on this floor plan. However, no warranties, either expressed or implied are made with respect to this floor plan. If the location of building columns, utilities or other architectural components of the facility is a consideration in the construction of an exhibit, it is the sole responsibility of the exhibitor to physically inspect the facility to verify all dimensions and locations.

MN Private College Job & Internship Fair

2/19/2025

Facility: Minneapolis Convention Center	Drawn By: HollisC
City & State: Minneapolis, MN	Show Number: 13327
Room Location: Hall A And Lobby A	Revised: 2/12/2025 7:27 PM
A.E. Mike Marigold	Drawing File: 13327_25_v07.dwg

Legend:

Pipe and Drape Report
13327 Pipe & Drape
02/12/2025

Type	Part Number	Qty	Description
Manually Placed:			
Base	10FTPOSTBASE	402	10" FRONT POST BASE
Base	8" Base	5	14x16 Base
Upright	8FTUP	5	8" Backwall
Upright	BP 8	230	BP 8 POST
Upright	FP 3	172	FP 3 POST
Support	8-12SUPP	4	8-12" Spreader
Support	REG-R6-10	373	REGULAR ROD 6'-10"

Drape Panels:	Material	Color	Qty	Height
	Banjo	Black	820	6'
	BANJO	BLUE	688	3'

